




FLOOR PLAN
Sewer Layout

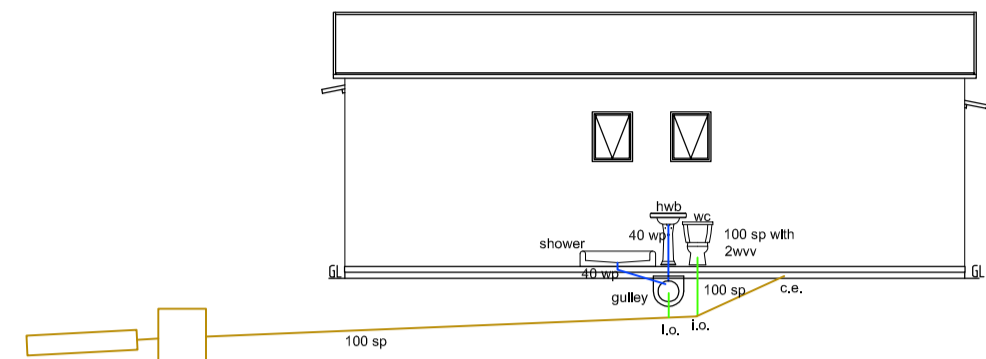


EAST ELEVATION
Scale 1:100

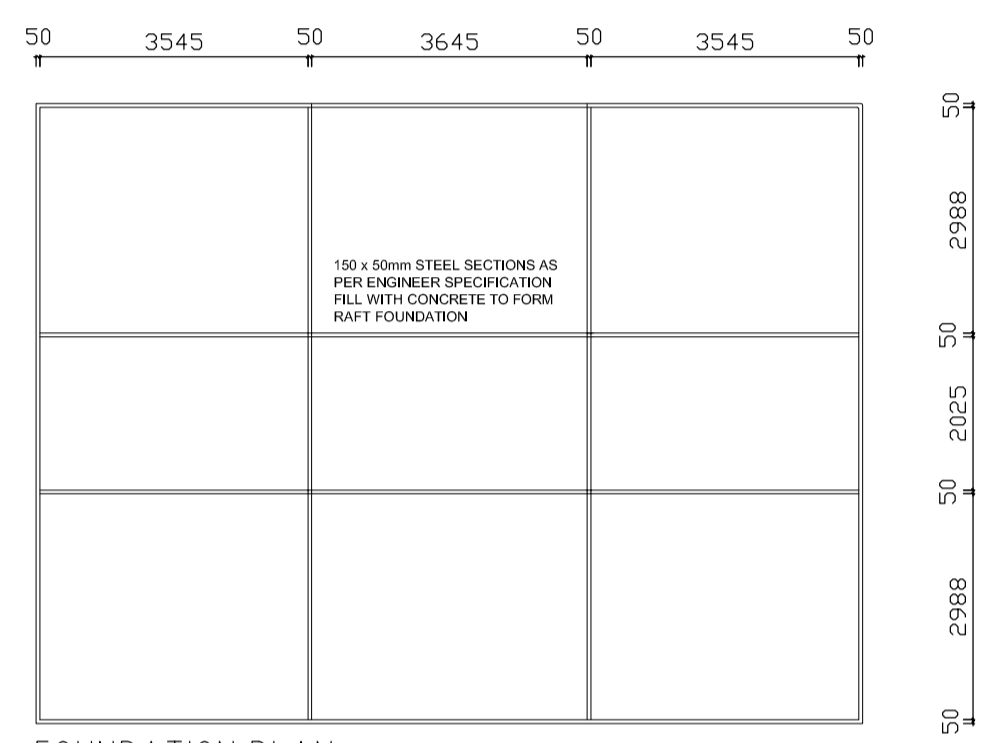


FOUNDATION PLAN
Scale 1:100

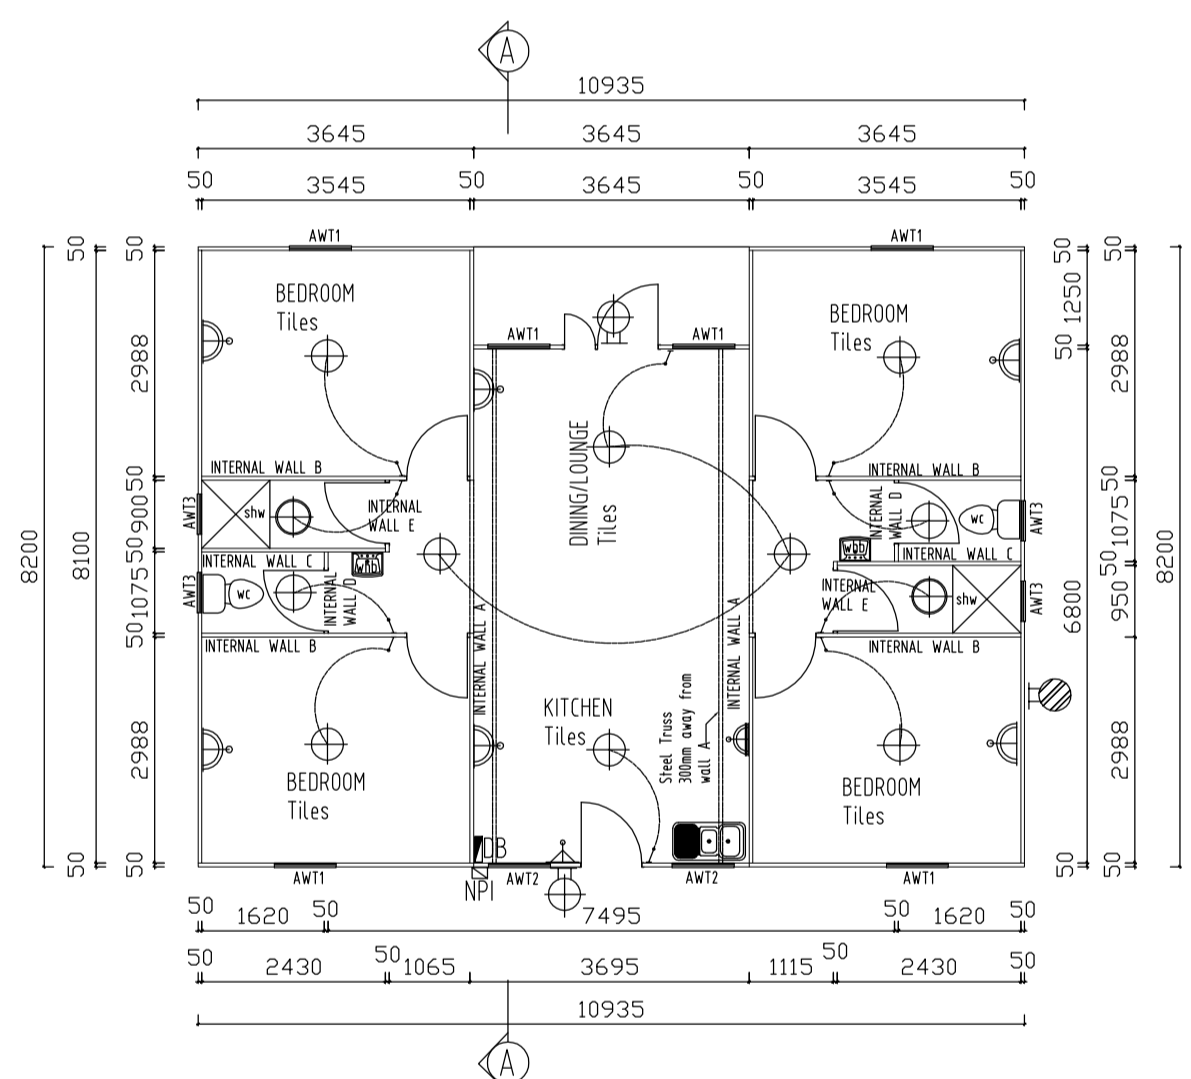


FLOOR PLAN
Scale 1:100 (Area 89.6m²)

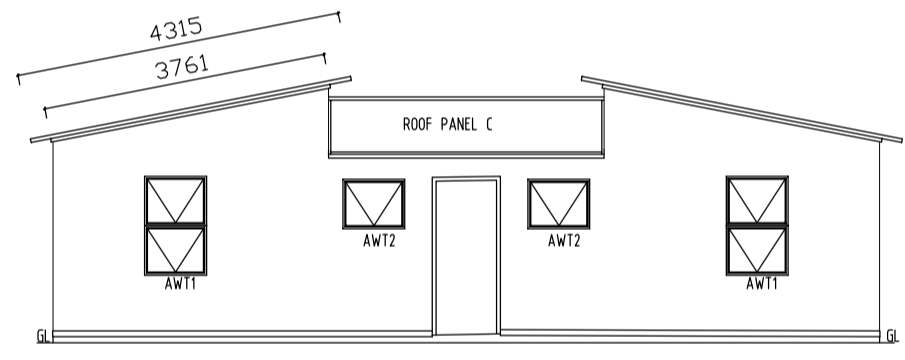


REAR ELEVATION
Scale 1:100

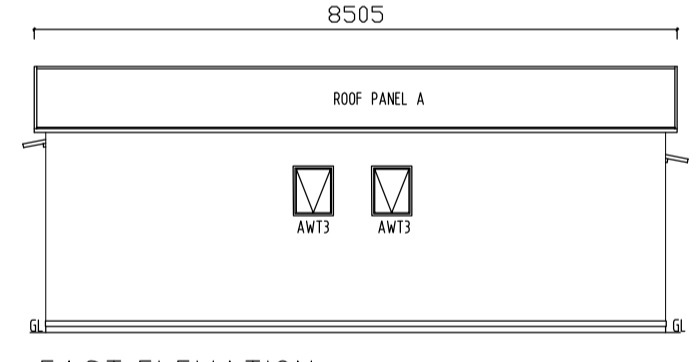

EAST ELEVATION
Scale 1:100

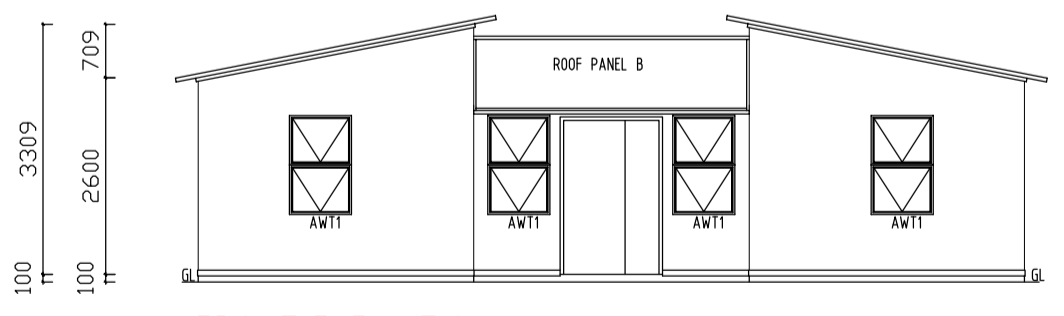

FRONT ELEVATION
Scale 1:100

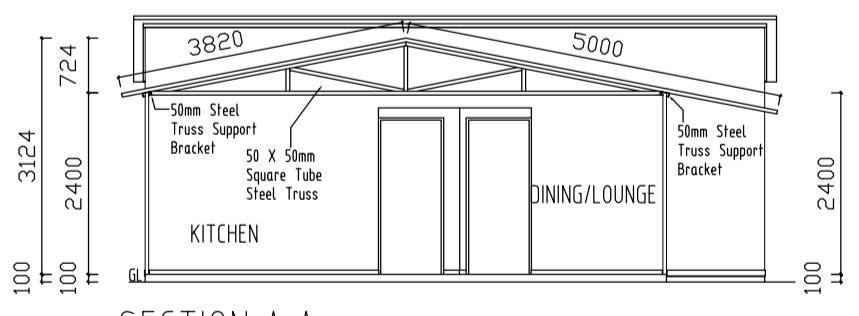

SECTION A.A
Scale 1:100

ELECTRICAL LEGEND

1	DB	Surface Mounted Distribution Board
1	NPI	Utility Box 120x80x55 (NPI Box)
10	⊕	Bulkhead Polycarb Ceiling mounted light
2	⊕	Waterproof Bulkhead light
2	⊕	Bulkhead Polycarb Wall mounted light
6	⊕	Double Wall Plug 350mm from FFL
1	⊕	Double Wall Plug 1200mm from FFL
0	⊕	Single Wall Plug
1	⊕	Stove Plug
10	⊕	Light switch
1	⊕	Day/Night Sensor



PROJECT: 90m² HOUSE FOR JUDEA HARVEST

DESCRIPTION: PLAN AND ELEVATIONS

DRAWN BY:	SCALE:	DATE:	CAD CODE:
SBU	1:100	10/2016	
CHECKED BY:	DWG No.:	REV. No.:	
		0	
REVISION:			
No.	DESCRIPTION		
0			

OPTION 1